

KITCHEN FLOOR PLAN

SCALE: 1/4" = 1'-0" North


PLUMBING SCHEDULE

ITEM NO.	EQUIPMENT CATEGORY	QTY	COLD WATER SIZE (IN)	COLD WATER AFF (IN)	HOT WATER SIZE (IN)	HOT WATER AFF (IN)	DIRECT DRAIN SIZE (IN)	INDIR DRAIN SIZE (IN)	GAS SIZE (IN)	MBTUH	GAS AFF (IN)	HOSE BIB BELOW	PLUMBING REMARKS
1	SINK, MOP	1	0.5	3/6	0.5	3/6	2						
2	SINK, HAND, WALL MOUNT	2	0.5	1/5	0.5	1/5	1.5	2.4					
3	SINK, SQUELTER, 1 COMPARTMENT	1	0.5	1/5	0.5	1/5							
10	OPEN, CONNECTION, ELECTRIC	1	0.5	3/0									
15	GELATO BATCH FREEZER	1	0.5	1/8					1.5				
16	MIXING MACHINE	1	0.5	1/3					1.5				
17	WAREWASHER, UNDERCOUNTER	1	0.375	1/8					0.375				
18	SINK, SQUELTER, 3 COMPARTMENTS	1	0.5	1/5	0.5	1/5	1/3	1.5					
32	ICE MAKER W/ BIN	1	0.375	3/8					1				
39	SINK, HAND, WALL MOUNT	1	0.5	1/5	0.5	1/5	1.5	2.4					
45	MERCHANDISER	1	0.5	2/5	4/8								
46	COFFEE MAKER, SATELLITE SYSTEM	1	0.375	3/0					0.75				
47	DIPPERWELL ASSEMBLY	1	0.375	3/0					0.75				
52	ESPRESSO EQUIPMENT	1	0.25	3/4					0.75				

PLUMBING CONNECTIONS NOTES

- P-NOTE 1: PLUMBING PLAN SHOWS ROOM-IN AND CONNECTION LOCATIONS WITH DIMENSIONS - SEE ROOM-IN DRAWINGS FINISHED BY THE LOCALTY. DIVISION IS SMALL FINISH AND INSTALL ALL PLUMBING CONNECTIONS IS RESPONSIBLE FOR ALL ELECTRICAL, MECHANICAL, AND PLUMBING CONNECTIONS AND REVISIONS, WITH ALL LOCAL CODES AND REGULATIONS AND WEST COUNTY.
- P-NOTE 2: ROOM-IN FOR WATER, WASTE, GAS AND STEAM SERVICES SHALL BE PROVIDED BY THE CONTRACTOR. ALL ROOM-IN SERVICES SHALL BE PROVIDED BY THE CONTRACTOR. ALL ROOM-IN SERVICES SHALL BE PROVIDED BY THE CONTRACTOR. ALL ROOM-IN SERVICES SHALL BE PROVIDED BY THE CONTRACTOR.
- P-NOTE 3: PROVIDE FIRE RATED MATERIALS AND/OR INSULATION AS REQUIRED FOR ALL ROOM-IN SERVICES. ALL ROOM-IN SERVICES SHALL BE PROVIDED BY THE CONTRACTOR. ALL ROOM-IN SERVICES SHALL BE PROVIDED BY THE CONTRACTOR.
- P-NOTE 4: PROVIDE FIRE RATED MATERIALS AND/OR INSULATION AS REQUIRED FOR ALL ROOM-IN SERVICES. ALL ROOM-IN SERVICES SHALL BE PROVIDED BY THE CONTRACTOR. ALL ROOM-IN SERVICES SHALL BE PROVIDED BY THE CONTRACTOR.
- P-NOTE 5: UNLESS INDICATED OTHERWISE ON PLAN, PROVIDE 1/2" THICK INSULATION ON ALL ROOM-IN SERVICES. ALL ROOM-IN SERVICES SHALL BE PROVIDED BY THE CONTRACTOR. ALL ROOM-IN SERVICES SHALL BE PROVIDED BY THE CONTRACTOR.
- P-NOTE 6: UNLESS INDICATED OTHERWISE ON PLAN, PROVIDE 1/2" THICK INSULATION ON ALL ROOM-IN SERVICES. ALL ROOM-IN SERVICES SHALL BE PROVIDED BY THE CONTRACTOR. ALL ROOM-IN SERVICES SHALL BE PROVIDED BY THE CONTRACTOR.
- P-NOTE 7: UNLESS INDICATED OTHERWISE ON PLAN, PROVIDE 1/2" THICK INSULATION ON ALL ROOM-IN SERVICES. ALL ROOM-IN SERVICES SHALL BE PROVIDED BY THE CONTRACTOR. ALL ROOM-IN SERVICES SHALL BE PROVIDED BY THE CONTRACTOR.
- P-NOTE 8: UNLESS INDICATED OTHERWISE ON PLAN, PROVIDE 1/2" THICK INSULATION ON ALL ROOM-IN SERVICES. ALL ROOM-IN SERVICES SHALL BE PROVIDED BY THE CONTRACTOR. ALL ROOM-IN SERVICES SHALL BE PROVIDED BY THE CONTRACTOR.
- P-NOTE 9: UNLESS INDICATED OTHERWISE ON PLAN, PROVIDE 1/2" THICK INSULATION ON ALL ROOM-IN SERVICES. ALL ROOM-IN SERVICES SHALL BE PROVIDED BY THE CONTRACTOR. ALL ROOM-IN SERVICES SHALL BE PROVIDED BY THE CONTRACTOR.
- P-NOTE 10: UNLESS INDICATED OTHERWISE ON PLAN, PROVIDE 1/2" THICK INSULATION ON ALL ROOM-IN SERVICES. ALL ROOM-IN SERVICES SHALL BE PROVIDED BY THE CONTRACTOR. ALL ROOM-IN SERVICES SHALL BE PROVIDED BY THE CONTRACTOR.
- P-NOTE 11: UNLESS INDICATED OTHERWISE ON PLAN, PROVIDE 1/2" THICK INSULATION ON ALL ROOM-IN SERVICES. ALL ROOM-IN SERVICES SHALL BE PROVIDED BY THE CONTRACTOR. ALL ROOM-IN SERVICES SHALL BE PROVIDED BY THE CONTRACTOR.
- P-NOTE 12: UNLESS INDICATED OTHERWISE ON PLAN, PROVIDE 1/2" THICK INSULATION ON ALL ROOM-IN SERVICES. ALL ROOM-IN SERVICES SHALL BE PROVIDED BY THE CONTRACTOR. ALL ROOM-IN SERVICES SHALL BE PROVIDED BY THE CONTRACTOR.
- P-NOTE 13: UNLESS INDICATED OTHERWISE ON PLAN, PROVIDE 1/2" THICK INSULATION ON ALL ROOM-IN SERVICES. ALL ROOM-IN SERVICES SHALL BE PROVIDED BY THE CONTRACTOR. ALL ROOM-IN SERVICES SHALL BE PROVIDED BY THE CONTRACTOR.
- P-NOTE 14: UNLESS INDICATED OTHERWISE ON PLAN, PROVIDE 1/2" THICK INSULATION ON ALL ROOM-IN SERVICES. ALL ROOM-IN SERVICES SHALL BE PROVIDED BY THE CONTRACTOR. ALL ROOM-IN SERVICES SHALL BE PROVIDED BY THE CONTRACTOR.
- P-NOTE 15: UNLESS INDICATED OTHERWISE ON PLAN, PROVIDE 1/2" THICK INSULATION ON ALL ROOM-IN SERVICES. ALL ROOM-IN SERVICES SHALL BE PROVIDED BY THE CONTRACTOR. ALL ROOM-IN SERVICES SHALL BE PROVIDED BY THE CONTRACTOR.
- P-NOTE 16: UNLESS INDICATED OTHERWISE ON PLAN, PROVIDE 1/2" THICK INSULATION ON ALL ROOM-IN SERVICES. ALL ROOM-IN SERVICES SHALL BE PROVIDED BY THE CONTRACTOR. ALL ROOM-IN SERVICES SHALL BE PROVIDED BY THE CONTRACTOR.
- P-NOTE 17: UNLESS INDICATED OTHERWISE ON PLAN, PROVIDE 1/2" THICK INSULATION ON ALL ROOM-IN SERVICES. ALL ROOM-IN SERVICES SHALL BE PROVIDED BY THE CONTRACTOR. ALL ROOM-IN SERVICES SHALL BE PROVIDED BY THE CONTRACTOR.
- P-NOTE 18: UNLESS INDICATED OTHERWISE ON PLAN, PROVIDE 1/2" THICK INSULATION ON ALL ROOM-IN SERVICES. ALL ROOM-IN SERVICES SHALL BE PROVIDED BY THE CONTRACTOR. ALL ROOM-IN SERVICES SHALL BE PROVIDED BY THE CONTRACTOR.
- P-NOTE 19: UNLESS INDICATED OTHERWISE ON PLAN, PROVIDE 1/2" THICK INSULATION ON ALL ROOM-IN SERVICES. ALL ROOM-IN SERVICES SHALL BE PROVIDED BY THE CONTRACTOR. ALL ROOM-IN SERVICES SHALL BE PROVIDED BY THE CONTRACTOR.
- P-NOTE 20: UNLESS INDICATED OTHERWISE ON PLAN, PROVIDE 1/2" THICK INSULATION ON ALL ROOM-IN SERVICES. ALL ROOM-IN SERVICES SHALL BE PROVIDED BY THE CONTRACTOR. ALL ROOM-IN SERVICES SHALL BE PROVIDED BY THE CONTRACTOR.
- P-NOTE 21: UNLESS INDICATED OTHERWISE ON PLAN, PROVIDE 1/2" THICK INSULATION ON ALL ROOM-IN SERVICES. ALL ROOM-IN SERVICES SHALL BE PROVIDED BY THE CONTRACTOR. ALL ROOM-IN SERVICES SHALL BE PROVIDED BY THE CONTRACTOR.
- P-NOTE 22: UNLESS INDICATED OTHERWISE ON PLAN, PROVIDE 1/2" THICK INSULATION ON ALL ROOM-IN SERVICES. ALL ROOM-IN SERVICES SHALL BE PROVIDED BY THE CONTRACTOR. ALL ROOM-IN SERVICES SHALL BE PROVIDED BY THE CONTRACTOR.
- P-NOTE 23: UNLESS INDICATED OTHERWISE ON PLAN, PROVIDE 1/2" THICK INSULATION ON ALL ROOM-IN SERVICES. ALL ROOM-IN SERVICES SHALL BE PROVIDED BY THE CONTRACTOR. ALL ROOM-IN SERVICES SHALL BE PROVIDED BY THE CONTRACTOR.
- P-NOTE 24: UNLESS INDICATED OTHERWISE ON PLAN, PROVIDE 1/2" THICK INSULATION ON ALL ROOM-IN SERVICES. ALL ROOM-IN SERVICES SHALL BE PROVIDED BY THE CONTRACTOR. ALL ROOM-IN SERVICES SHALL BE PROVIDED BY THE CONTRACTOR.
- P-NOTE 25: UNLESS INDICATED OTHERWISE ON PLAN, PROVIDE 1/2" THICK INSULATION ON ALL ROOM-IN SERVICES. ALL ROOM-IN SERVICES SHALL BE PROVIDED BY THE CONTRACTOR. ALL ROOM-IN SERVICES SHALL BE PROVIDED BY THE CONTRACTOR.
- P-NOTE 26: UNLESS INDICATED OTHERWISE ON PLAN, PROVIDE 1/2" THICK INSULATION ON ALL ROOM-IN SERVICES. ALL ROOM-IN SERVICES SHALL BE PROVIDED BY THE CONTRACTOR. ALL ROOM-IN SERVICES SHALL BE PROVIDED BY THE CONTRACTOR.
- P-NOTE 27: UNLESS INDICATED OTHERWISE ON PLAN, PROVIDE 1/2" THICK INSULATION ON ALL ROOM-IN SERVICES. ALL ROOM-IN SERVICES SHALL BE PROVIDED BY THE CONTRACTOR. ALL ROOM-IN SERVICES SHALL BE PROVIDED BY THE CONTRACTOR.
- P-NOTE 28: UNLESS INDICATED OTHERWISE ON PLAN, PROVIDE 1/2" THICK INSULATION ON ALL ROOM-IN SERVICES. ALL ROOM-IN SERVICES SHALL BE PROVIDED BY THE CONTRACTOR. ALL ROOM-IN SERVICES SHALL BE PROVIDED BY THE CONTRACTOR.
- P-NOTE 29: UNLESS INDICATED OTHERWISE ON PLAN, PROVIDE 1/2" THICK INSULATION ON ALL ROOM-IN SERVICES. ALL ROOM-IN SERVICES SHALL BE PROVIDED BY THE CONTRACTOR. ALL ROOM-IN SERVICES SHALL BE PROVIDED BY THE CONTRACTOR.
- P-NOTE 30: UNLESS INDICATED OTHERWISE ON PLAN, PROVIDE 1/2" THICK INSULATION ON ALL ROOM-IN SERVICES. ALL ROOM-IN SERVICES SHALL BE PROVIDED BY THE CONTRACTOR. ALL ROOM-IN SERVICES SHALL BE PROVIDED BY THE CONTRACTOR.

PLUMBING CONNECTIONS

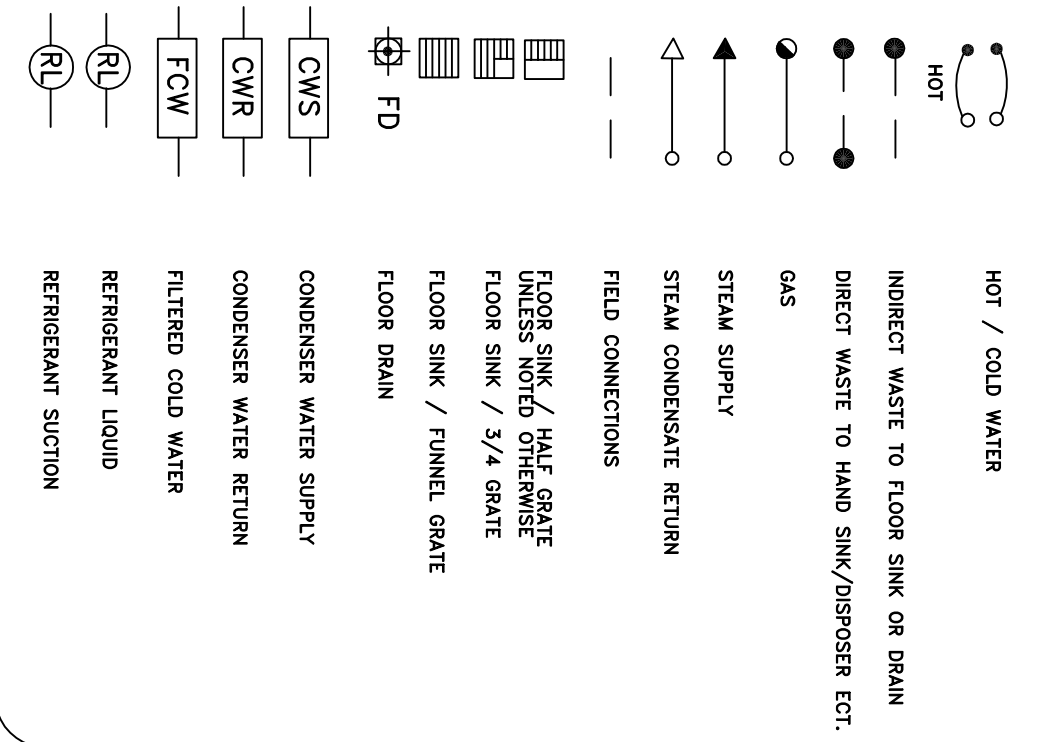

PLUMBING PLAN and SCHEDULE

3PM DESIGN
 Foodservice Consulting &
 For-her, Colorado
 80134
 Tel: (303) 840-0883
 Fax: (303) 840-0885
 Email: info@3pmdesign.com

DATE: 04/23/08
 CHECKED BY: PM
 DRAWN BY: PM
 SCALE: 1/4" = 1'-0"
 JOB NUMBER: G2-11-08
 SHEET NUMBER: KAL1.2

RED BIRD CAFE
 11405 E. BRIARWOOD AVENUE

REVISIONS: